



SITE PLAN
SCALE 1:100

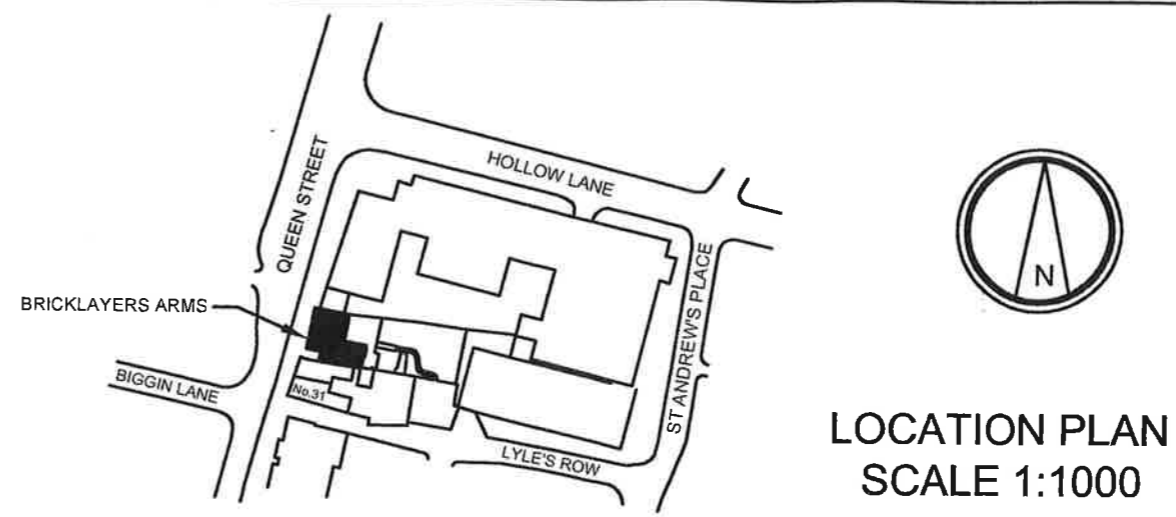

LOCATION PLAN
SCALE 1:1000

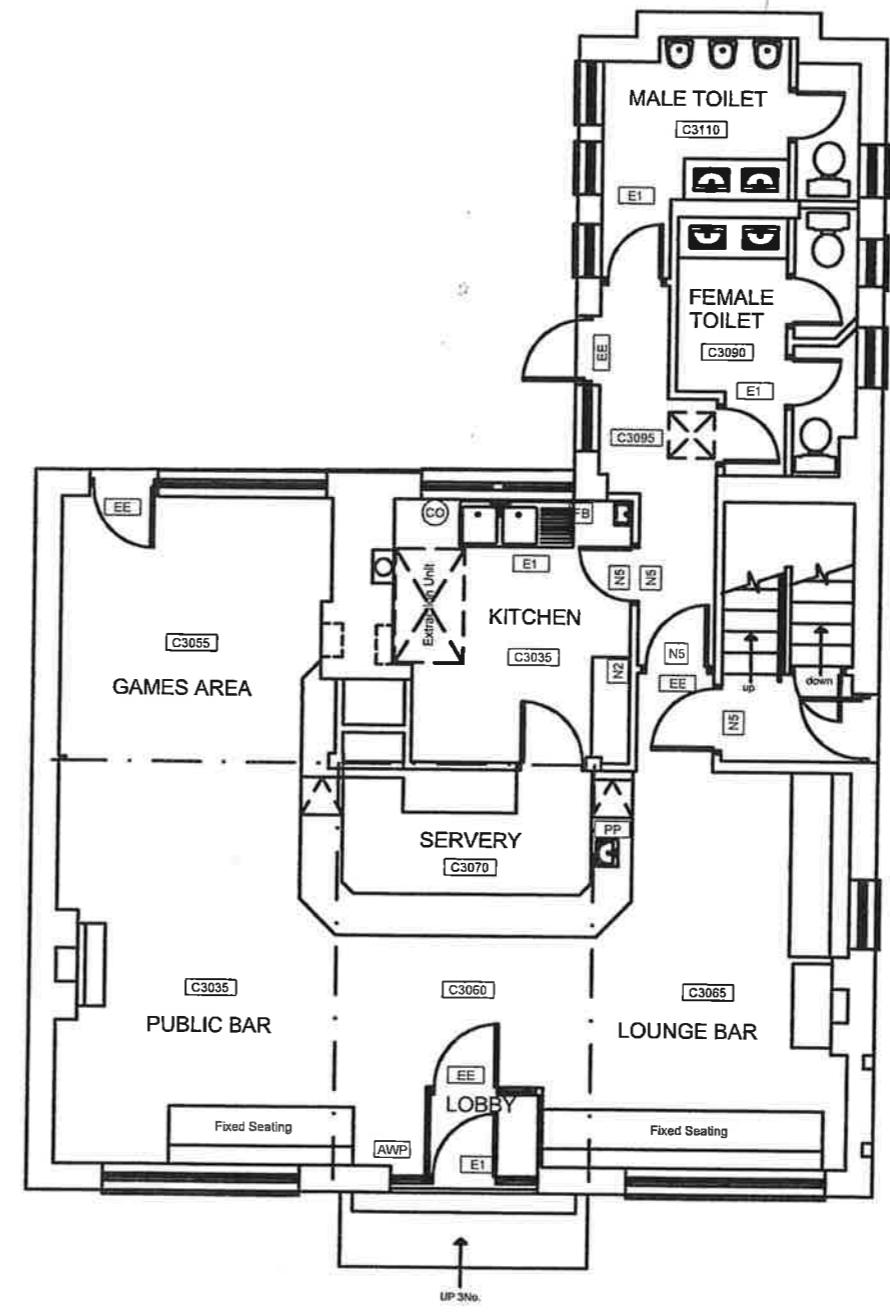

EXISTING GROUND FLOOR PLAN 2004
SCALE 1:50

- KEY**
- [N1] General Fire Notice
 - [N2] Staff Fire Notice
 - [N3] 'Fire Door Keep Locked' sign
 - [N4] 'Fire Exit Keep Clear' sign
 - [N5] 'Fire Door Keep Closed' sign
 - [FB] Fire Blanket
 - [DP] Dry Powder Fire Extinguisher
 - [CO] Carbon Dioxide Fire Extinguisher
 - [FO] Foam Fire Extinguisher
 - [WA] Water Fire Extinguisher
 - [E1] Emergency Light Fitting
 - [EE] Emergency Exit Sign
 - [H] Heat Detector
 - [S] Smoke Detector
 - [C] Break Glass Call Point
 - [L] Fire Alarm Sounder
 - [FAP] Fire Alarm Panel
 - [AWP] Amusement with Prizes
 - [SWP] Skill with Prizes
 - [ATM] Cash machines
 - [PP] Pay Phone
 - [C2860] Ceiling Height

CHARLES WELLS LTD.,
JOHN R. LEAHY R.I.B.A.
CHIEF ARCHITECT
THE BISHOPRY, HAYLOCK STREET,
BEDFORD MK40 4JJ. TEL: 01294 575708

HOUSE
THE BRICKLAYERS ARMS
QUEEN STREET
HITCHIN

DRAWN
EXISTING GROUND FLOOR PLAN

SCALE 1:50
DATE NOVEMBER 2004
DRAWN BY CFS

DRAWING No. **B26**