



**NOTE:**  
Do not scale off this drawing. All dimensions to be checked on site by the Contractor. Any discrepancies to be reported to the Architect.

- KEY**
- [N1] General Fire Notice
  - [N2] Staff Fire Notice
  - [N3] 'Fire Door Keep Locked' sign
  - [N4] 'Fire Exit Keep Clear' sign
  - [N5] 'Fire Door Keep Closed' sign
  - [FB] Fire Blanket
  - [DP] Dry Powder Fire Extinguisher
  - [CO] Carbon Dioxide Fire Extinguisher
  - [FO] Foam Fire Extinguisher
  - [WA] Water Fire Extinguisher
  - [E1] Emergency Light Fitting
  - [EE] Emergency Exit Sign
  - [H] Heat Detector
  - [S] Smoke Detector
  - [C] Break Glass Call Point
  - [FAS] Fire Alarm Sounder
  - [FAP] Fire Alarm Panel
  - [AWP] Amusement with Prizes
  - [SWP] Skill with Prizes
  - [ATM] Cash machines
  - [PP] Pay Phone
  - [CE2880] Ceiling Height

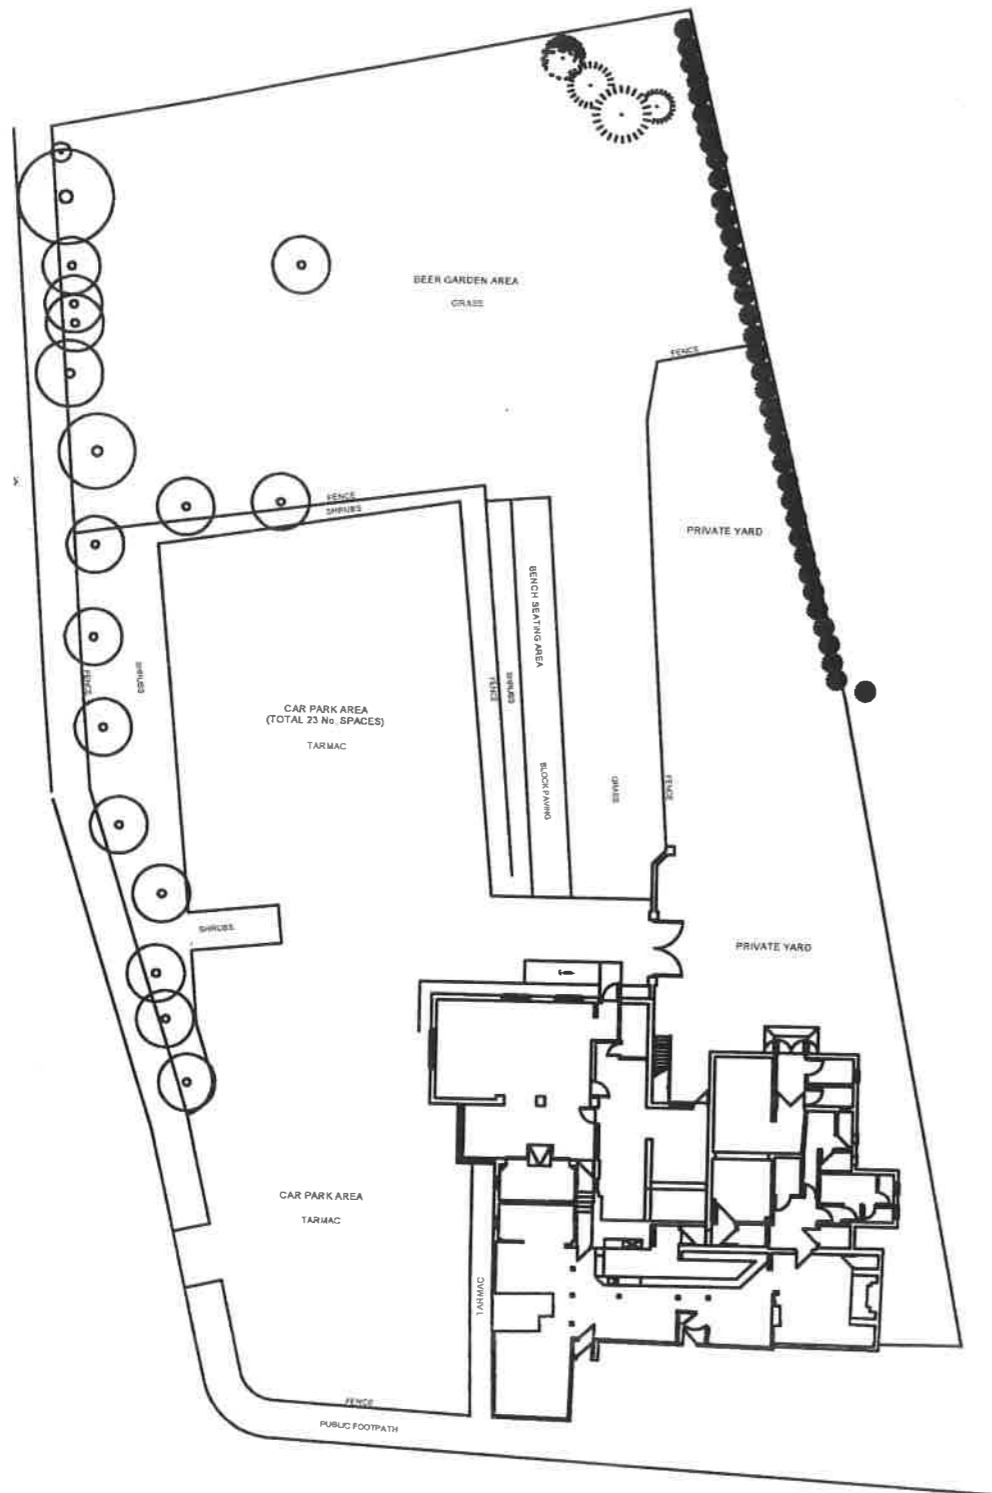

SITE PLAN  
SCALE 1:200

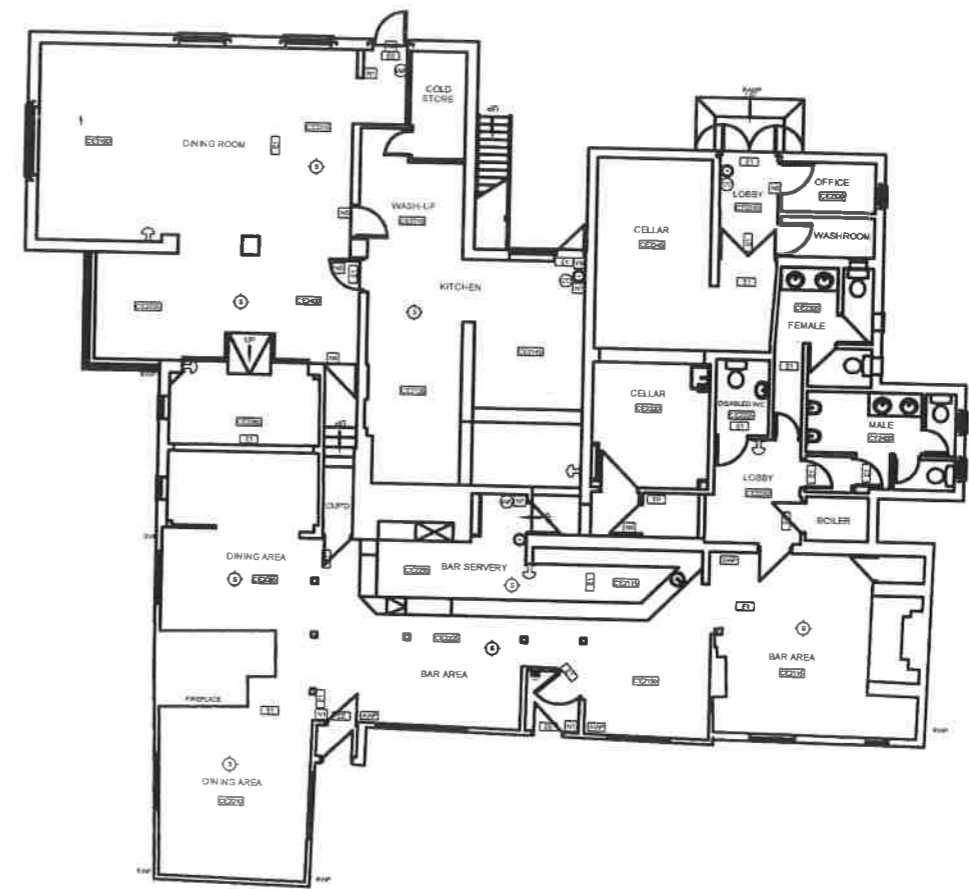

EXISTING GROUND FLOOR PLAN 2005  
SCALE 1:100



PROPERTY SERVICES DEPARTMENT  
THE BREWERY, HAYSTACK STREET,  
BENFORD MK40 4JJ.  
Tel: 01294 276708 Fax: 01294 706008

HOUSE  
**THE KING WILLIAM IV**

**KEMPSTON**

**DRAWING**

**EXISTING GROUND FLOOR LAYOUT**

SCALE 1:100

DATE FEBRUARY 2005

DRAWN BY CPS

DRAWING No.

**K3**