



NOTE:
Do not scale off this drawing. All dimensions to be checked on site by the Contractor. Any discrepancy to be reported to the Architect.

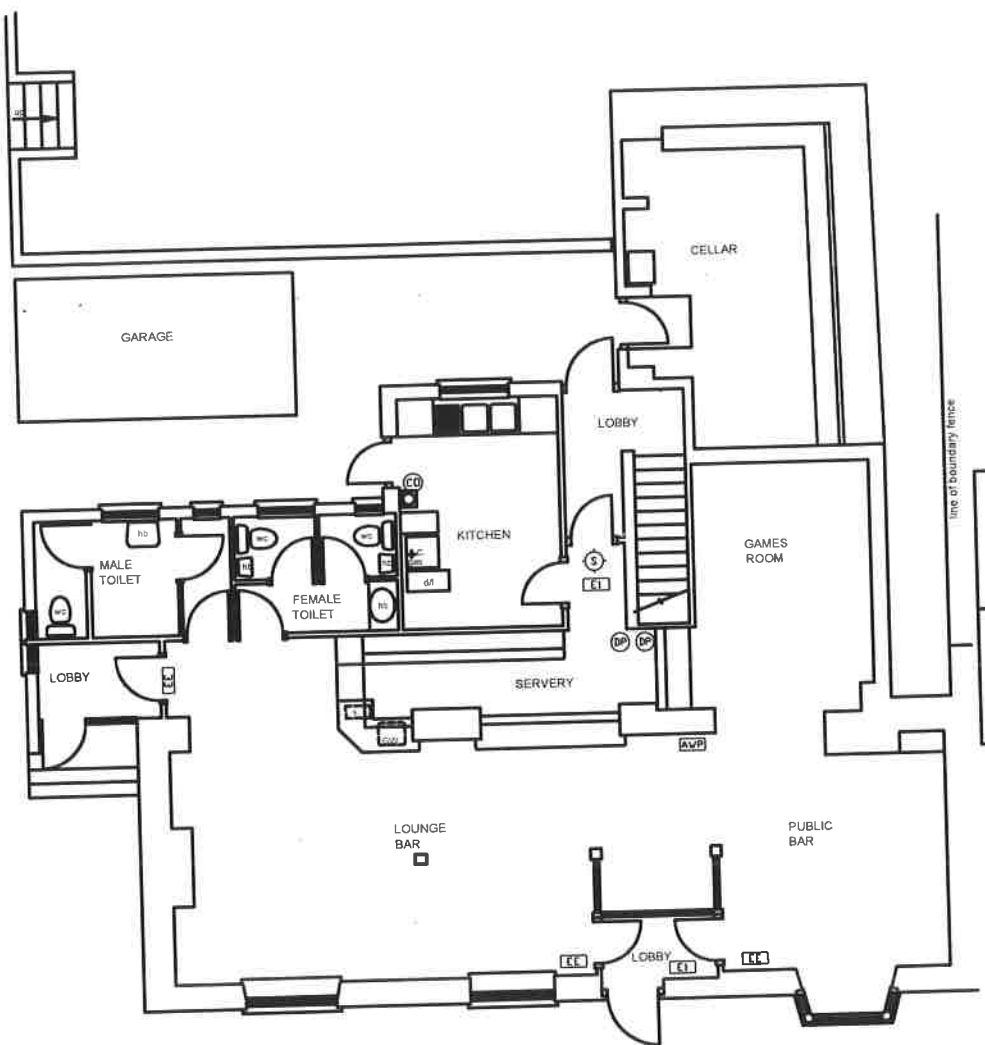

GROUND FLOOR PLAN

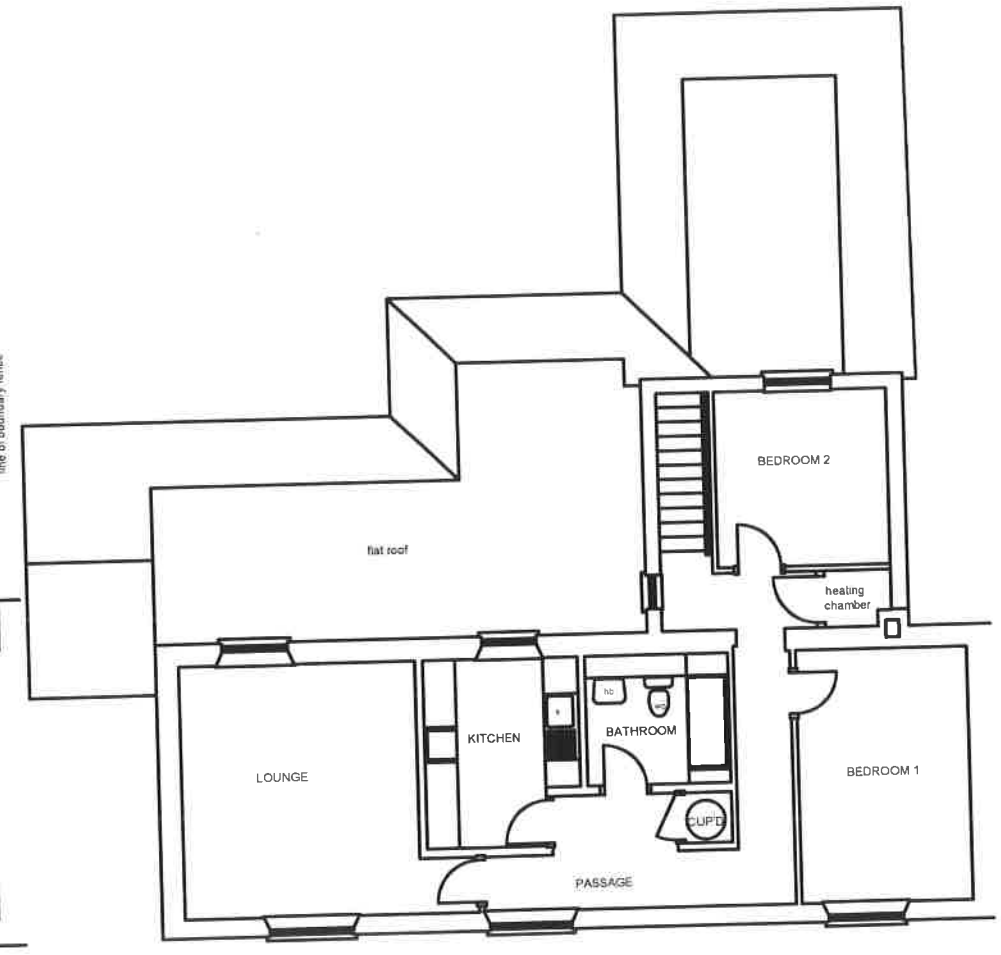

FIRST FLOOR PLAN

KEY

N1	General Fire Notice
N2	Staff Fire Notice
N3	'Fire Door Keep Locked' sign
N4	'Fire Exit Keep Clear' sign
FB	Fire Blanket
DP	Dry Powder Fire Extinguisher
CD	Carbon Dioxide Fire Extinguisher
FD	Foam Fire Extinguisher
VA	Water Fire Extinguisher
EL	Emergency Light Fitting
EE	Emergency Exit Sign
H	Heat Detector
S	Smoke Detector
C	Break Glass Call Point
SA	Fire Alarm Sounder
FAP	Fire Alarm Panel
AVP	Amusement with Prizes
SVP	Skill with Prizes
ATM	Cash machines
PP	Pay Phone



PROPERTY SERVICES DEPARTMENT
THE HERBERT, HAYLOCK STREET,
BIRMINGHAM B3 4JL.
Tel: 0121 424 275700 Fax: 0121 424 764000

HOURS
HALF MOON
42 MAIN ROAD
GRENDON

DRAWING
GROUND & FIRST
FLOOR PLANS
SCALE 1:100
DATE SEPT '98
DRAWN BY FM
DRAWING No.
H1