




This Drawing is not to be scaled. The General Contractor is to check all dimensions and notify The Architect of any discrepancies or omissions.

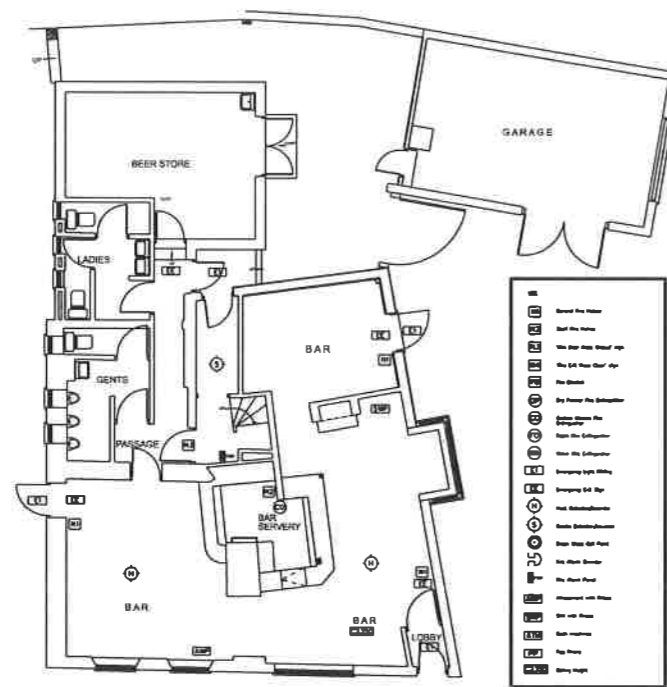

GROUND FLOOR PLAN 1:100

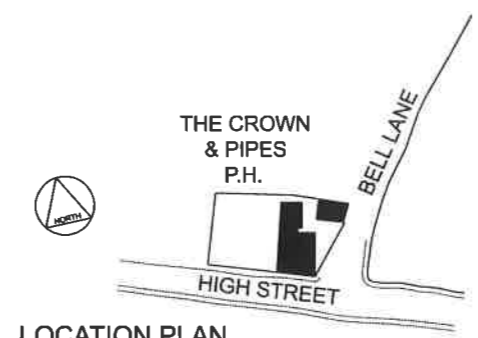

LOCATION PLAN
1 : 1000

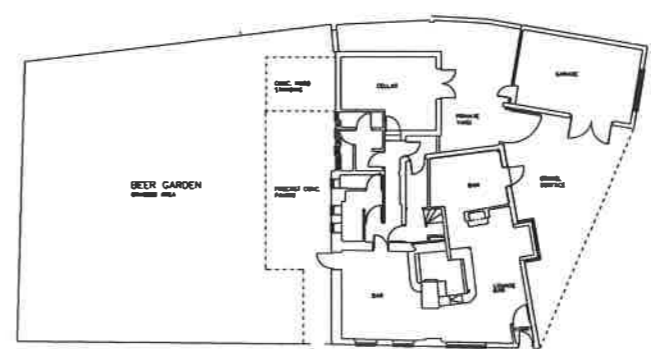

SITE PLAN 1:200

BELL SLATER	
<small>The Bell Slater Partnership 180 Upper Richmond Road Putney, London SW15 2SN Telephone 0181 788 3030 Fax 0181 788 2934 e-mail bap@bellslater.com Architects and Interior Designers</small>	
Client	CHARLES WELLS LTD
Project	THE CROWN & PIPE FENSTANTON
Title	GROUND FLOOR PLAN
CAD ref	Scale 1:100 (A1)
Drawn by	ME Date 22/03/04
Job number	Drawing No
1738	110