




NOTE:
Do not make off this drawing. All dimensions to be checked on site by the Contractor. Any discrepancy to be reported to the Architect.

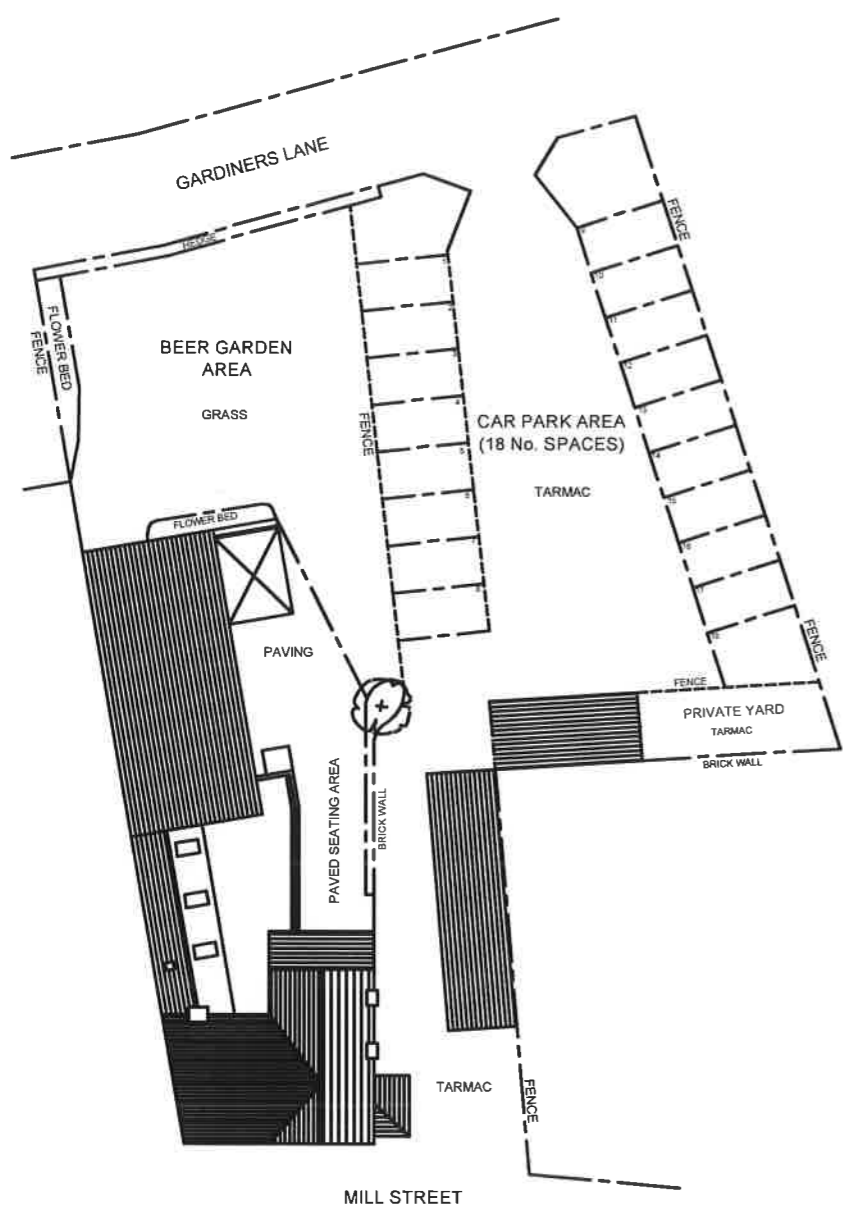


SITE PLAN
SCALE 1:200

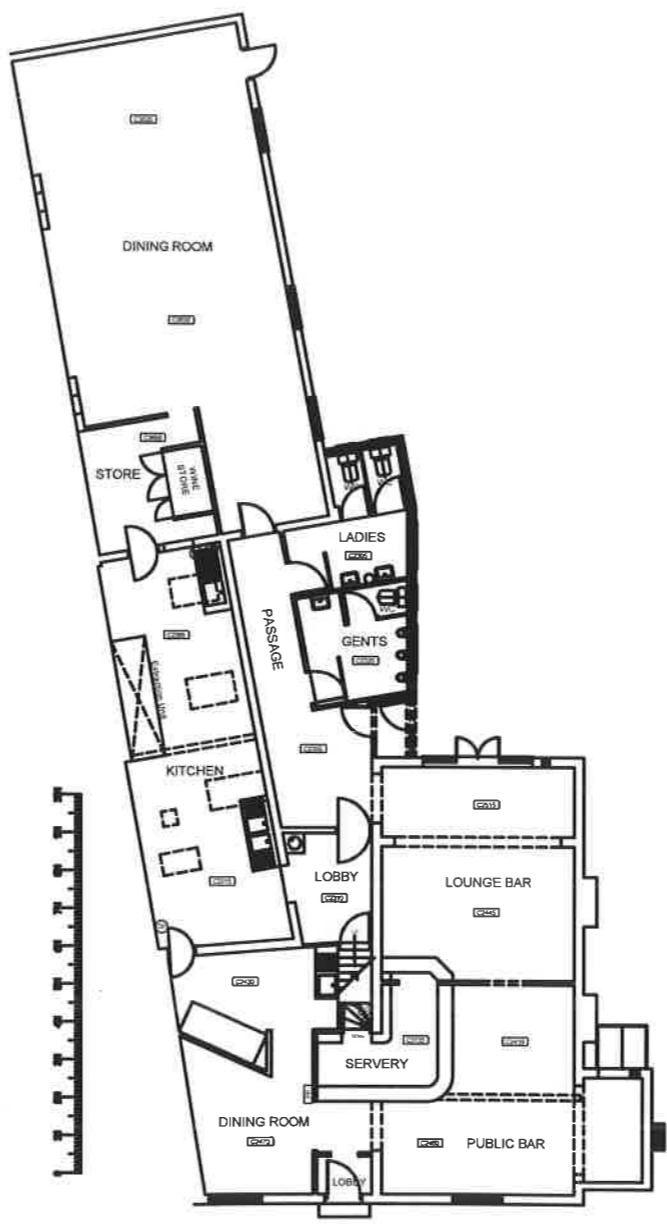

EXISTING GROUND FLOOR PLAN 2004
SCALE 1:100

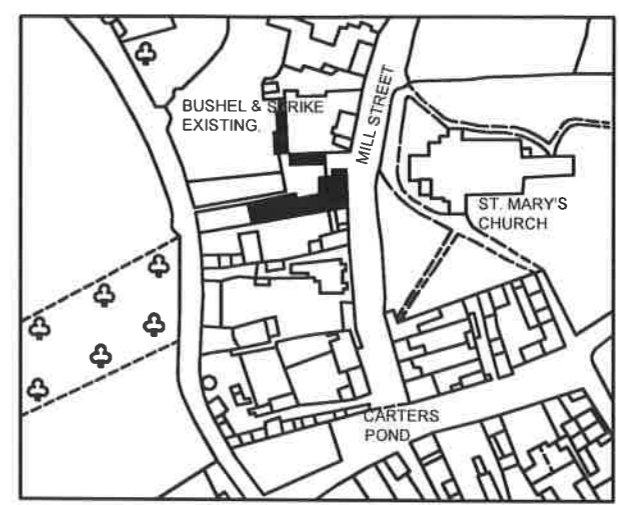


O.S. SHEET HERTS IV9
LOCATION PLAN
SCALE 1:1250

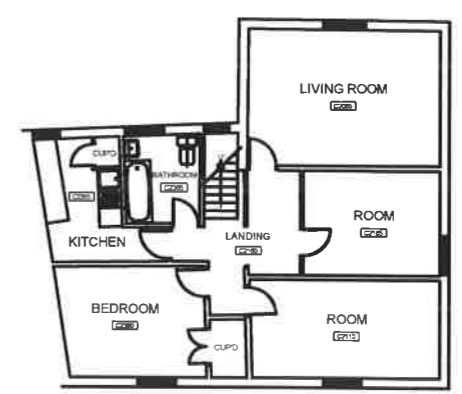

EXISTING FIRST FLOOR PLAN 2005
SCALE 1:100

KEY

- [N1] General Fire Notice
- [N2] Staff Fire Notice
- [N3] 'Fire Door Keep Locked' sign
- [N4] 'Fire Exit Keep Clear' sign
- [N5] 'Fire Door Keep Closed' sign
- [FB] Fire Blanket
- [DP] Dry Powder Fire Extinguisher
- [CO] Carbon Dioxide Fire Extinguisher
- [FO] Foam Fire Extinguisher
- [WA] Water Fire Extinguisher
- [E1] Emergency Light Fitting
- [EE] Emergency Exit Sign
- [H] Heat Detector
- [S] Smoke Detector
- [C] Break Glass Call Point
- [FAS] Fire Alarm Sounder
- [FAP] Fire Alarm Panel
- [AWP] Amusement with Prizes
- [SWP] Skill with Prizes
- [ATM] Cash machines
- [PP] Pay Phone
- [C2860] Ceiling Height


CHARLES WELLS
PROPERTY SERVICES DEPARTMENT
THE BREWERY, RAVELOCK STREET,
BEDFORD MK40 4LJ.
Tel: 01234 572700 Fax: 01234 701000

BUSHEL & STRIKE P.H.

ASHWELL
DRAWING

EXISTING GROUND & FIRST FLOOR PLAN

SCALE AS SHOWN
DATE APRIL 2005
DRAWN BY CPS

DRAWING No.
B30