



**SITE PLAN**  
SCALE 1:200

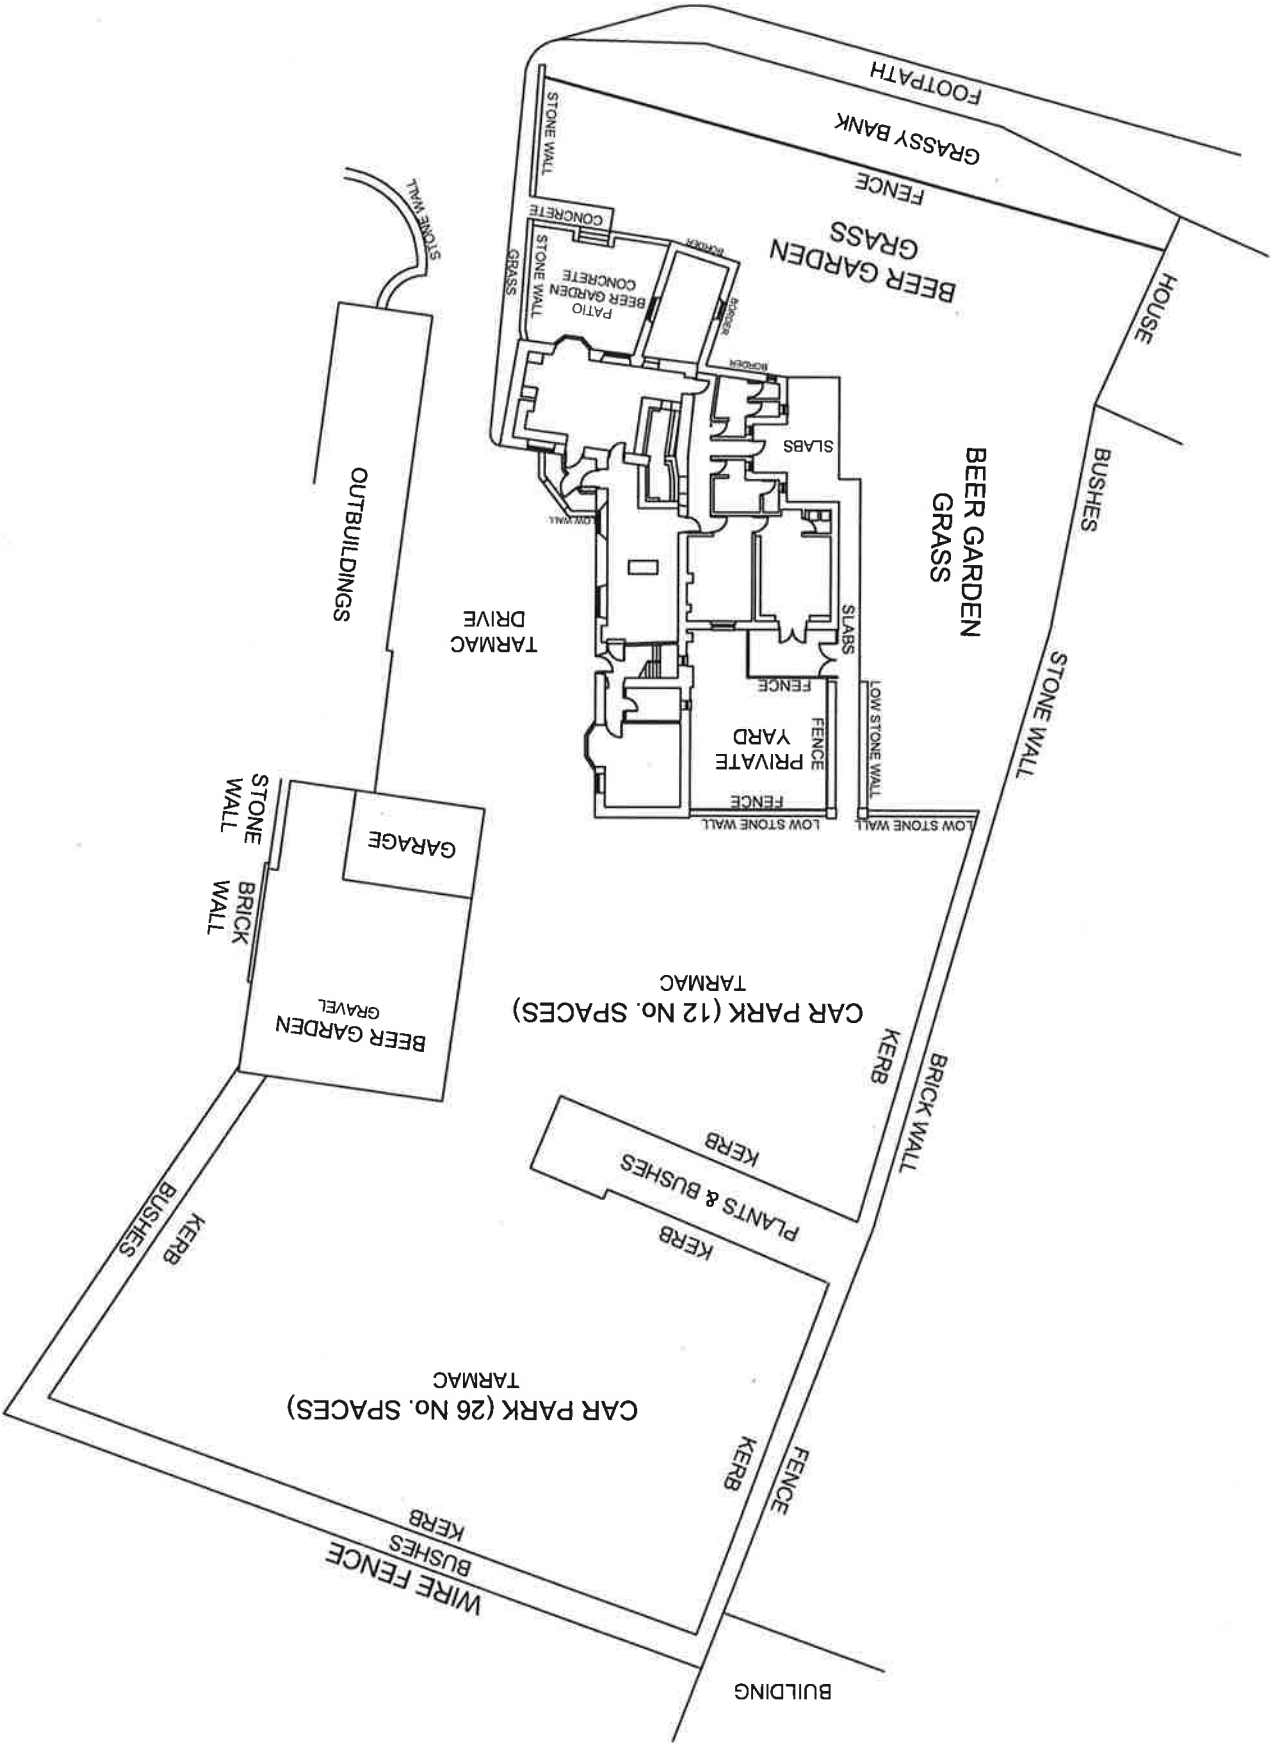

**EXISTING GROUND FLOOR PLAN 2004**  
SCALE 1:100

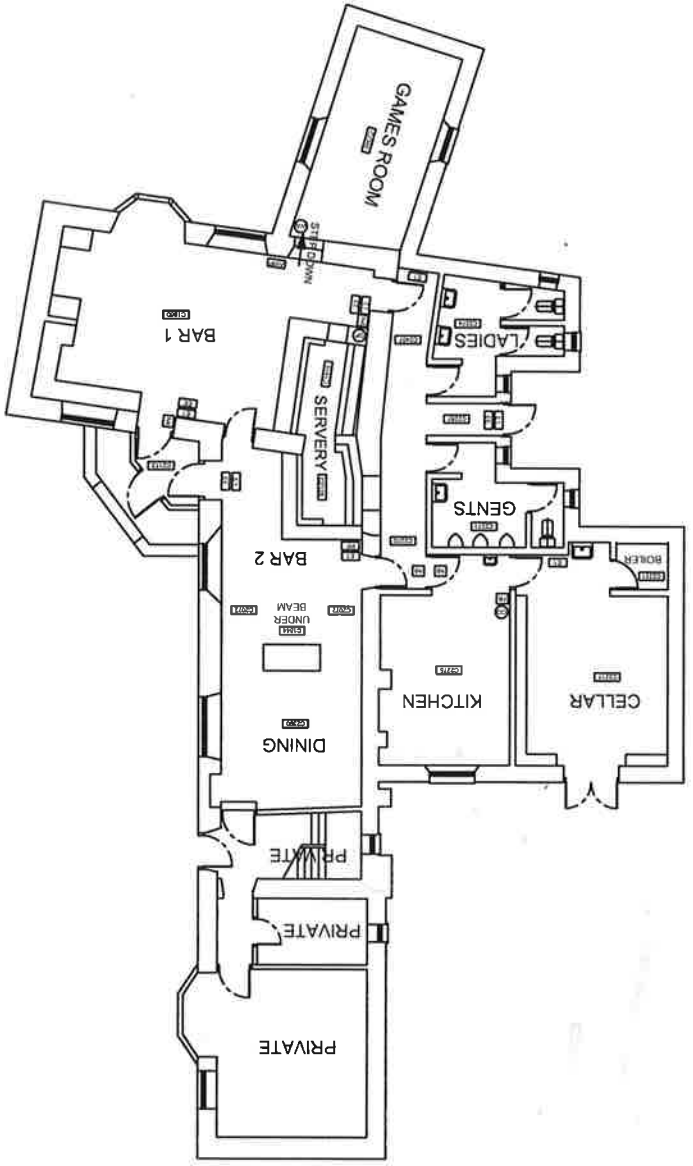

**R8**  
DRAWING No.

**DRAWN BY** DMC  
**DATE** NOVEMBER 2004  
**SCALE** 1:200 & 1:100

**EXISTING GROUND FLOOR PLAN**

**DRAWING**  
NORTHAMPTON  
YARDLEY HASTINGS  
RED LION  
HOUSE

**PROPERTY SERVICES DEPARTMENT**  
THE BREWERY, HAVLOCK STREET,  
THE REDFORD MK40 4JU.  
Tel: 01294 272786 Fax: 01294 761066

**CHARLES WELLS**

**KEY**

- [N1] General Fire Notice
- [N2] Staff Fire Notice
- [N3] Fire Door Keep Locked sign
- [N4] Fire Exit Keep Clear sign
- [N5] Fire Door Keep Closed sign
- [FB] Fire Blanket
- [DP] Dry Powder Fire Extinguisher
- [CO] Carbon Dioxide Fire Extinguisher
- [FO] Foam Fire Extinguisher
- [WA] Water Fire Extinguisher
- [ET] Emergency Light Fitting
- [EE] Emergency Exit Sign
- [H] Heat Detector
- [S] Smoke Detector
- [C] Break Glass Call Point
- [U] Fire Alarm Sounder
- [A] Fire Alarm Panel
- [AMP] Amusement with Prizes
- [SWP] Skill with Prizes
- [ATM] Cash machines
- [PP] Pay Phone
- [C2860] Ceiling Height

**NOTE:** Do not scale off this drawing. All dimensions to be checked on site by the Contractor. Any discrepancy to be reported to the Architect.