





EXISTING FIRST FLOOR PLAN 2005
SCALE 1:100

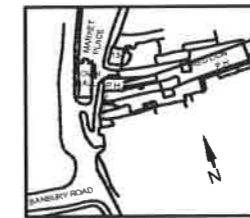

LOCATION PLAN
SCALE 1:2500

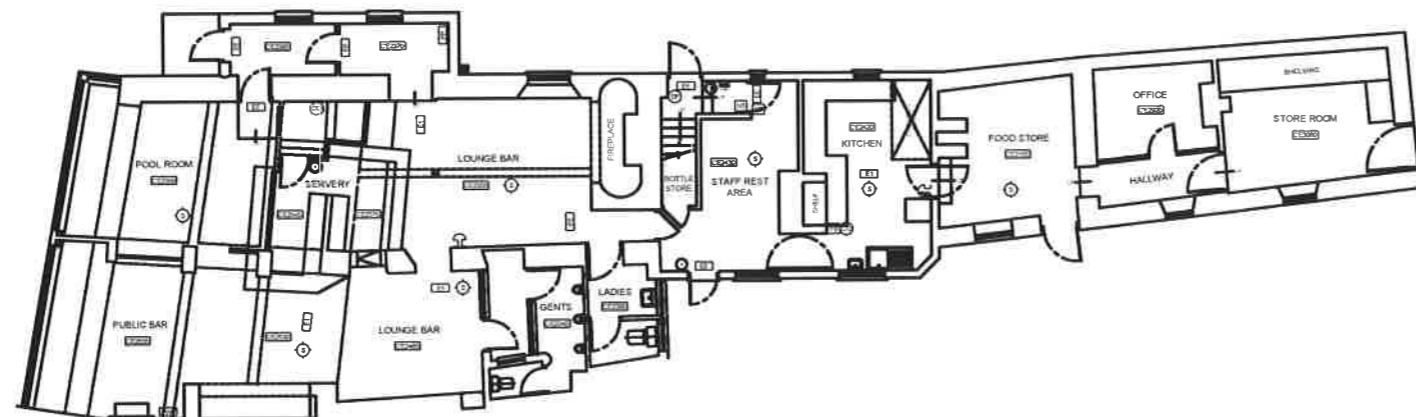

EXISTING GROUND FLOOR PLAN 2005
SCALE 1:100

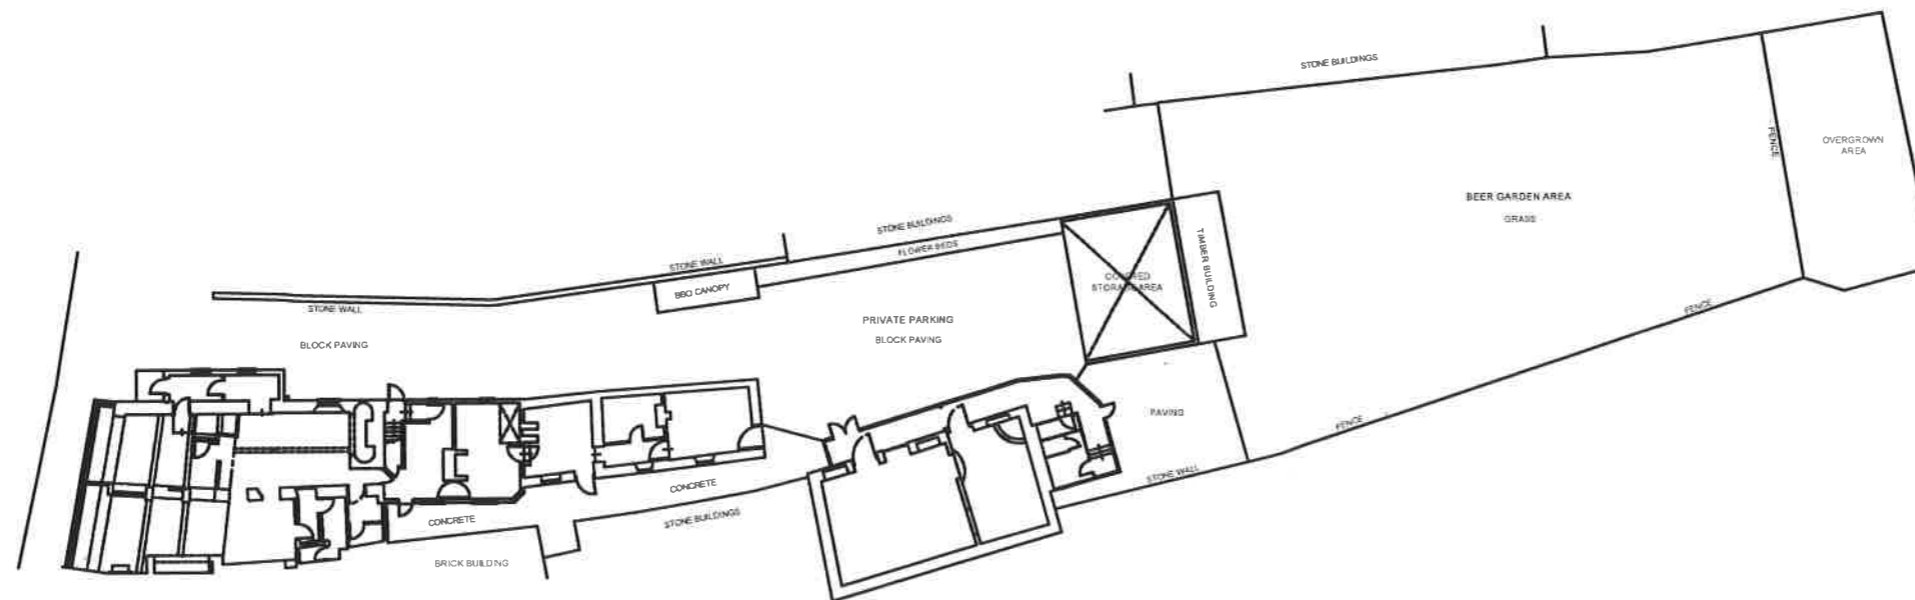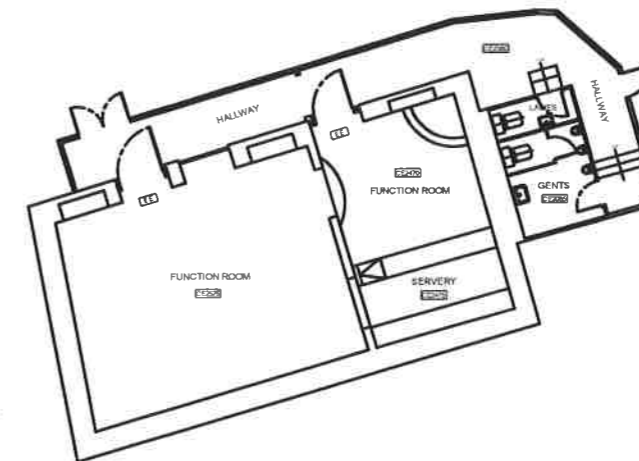

SITE PLAN
SCALE 1:200

NOTE:
Do not make off this drawing. All dimensions to be checked on site by the Contractor. Any discrepancy to be reported to the Architect.

- KEY**
- [N1] General Fire Notice
 - [N2] Staff Fire Notice
 - [N3] 'Fire Door Keep Locked' sign
 - [N4] 'Fire Exit Keep Clear' sign
 - [N5] 'Fire Door Keep Closed' sign
 - [FB] Fire Blanket
 - [DP] Dry Powder Fire Extinguisher
 - [CO] Carbon Dioxide Fire Extinguisher
 - [FO] Foam Fire Extinguisher
 - [WA] Water Fire Extinguisher
 - [E1] Emergency Light Fitting
 - [EE] Emergency Exit Sign
 - [H] Heat Detector
 - [S] Smoke Detector
 - [C] Break Glass Call Point
 - [FAS] Fire Alarm Sounder
 - [FAP] Fire Alarm Panel
 - [AWP] Amusement with Prizes
 - [SWP] Skill with Prizes
 - [ATM] Cash machines
 - [PP] Pay Phone
 - [CE2860] Ceiling Height



CHARLES WELLS
PROPERTY SERVICES DEPARTMENT
THE BREWERY, HAVELOCK STREET,
BEDFORD MK40 4LJ.
Tel. 01234 272700 Fax. 01234 761000

THE RED LION
11, MARKET PLACE,
BRACKLEY, NORTHANTS.

EXISTING GROUND & FIRST FLOOR PLANS

SCALE 1:100
DATE FEBRUARY 2005
DRAWN BY CPS

DRAWING No.
R3A