



NOTE:
Do not scale off this drawing. All dimensions to be checked on site by the Contractor. Any discrepancy to be reported to the Architect.

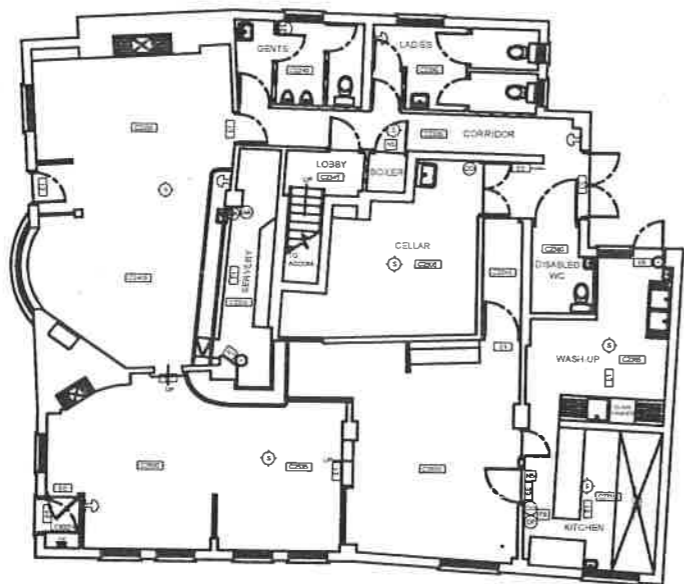


EXISTING GROUND FLOOR PLAN 2004
SCALE 1:100

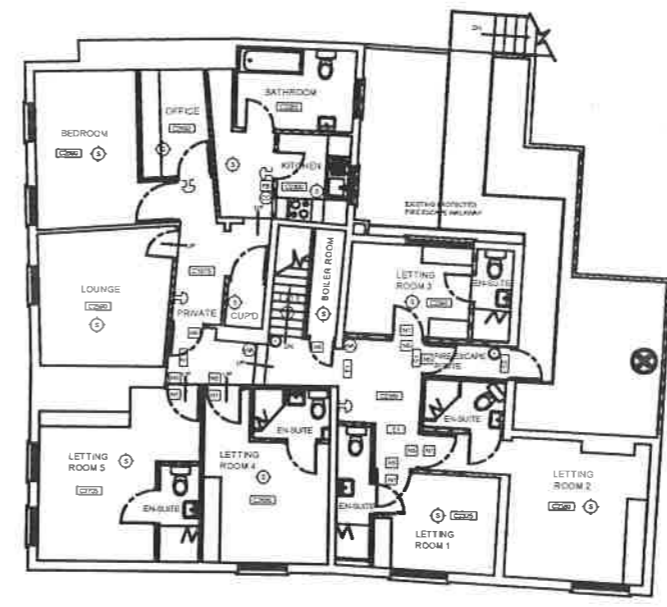


EXISTING FIRST FLOOR PLAN 2004
SCALE 1:100


- KEY**
- [N1] General Fire Notice
 - [N2] Staff Fire Notice
 - [N3] 'Fire Door Keep Locked' sign
 - [N4] 'Fire Exit Keep Clear' sign
 - [N5] 'Fire Door Keep Closed' sign
 - [FB] Fire Blanket
 - [DP] Dry Powder Fire Extinguisher
 - [CO] Carbon Dioxide Fire Extinguisher
 - [FO] Foam Fire Extinguisher
 - [WA] Water Fire Extinguisher
 - [E1] Emergency Light Fitting
 - [EE] Emergency Exit Sign
 - [H] Heat Detector
 - [S] Smoke Detector
 - [CG] Break Glass Call Point
 - [FAS] Fire Alarm Sounder
 - [FAP] Fire Alarm Panel
 - [AWP] Amusement with Prizes
 - [SWP] Skill with Prizes
 - [ATM] Cash machines
 - [PP] Pay Phone
 - [C2860] Ceiling Height

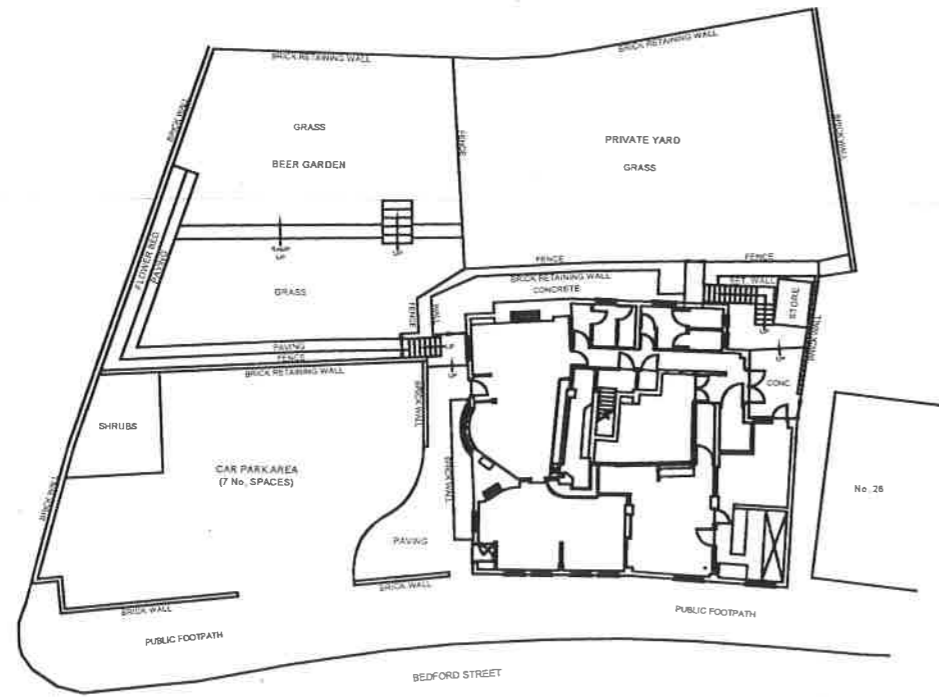

SITE PLAN
SCALE 1:200

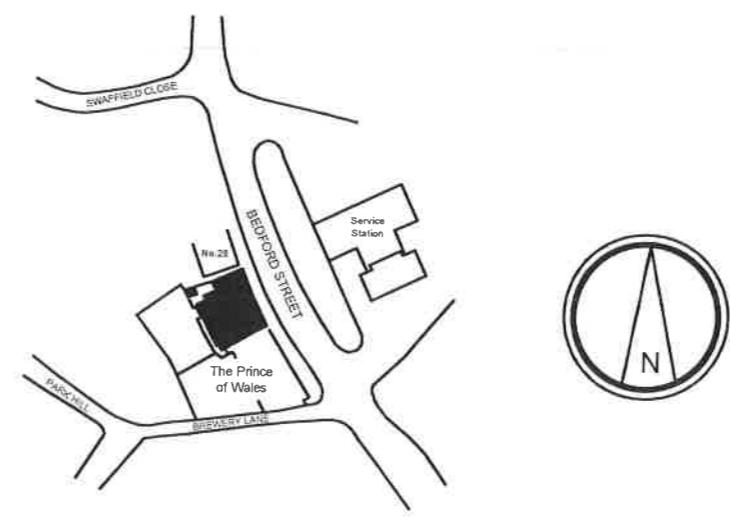

LOCATION PLAN
SCALE 1:1000



CHARLES WELLS

PROPERTY SERVICES DEPARTMENT
THE BARNBY, HAYLOCK STREET,
BEDFORD MK40 4LL
Tel: 01234 272708 Fax: 01234 761066

WORK
THE PRINCE OF WALES
AMPTHILL

DRAWING
EXISTING GROUND & FIRST
FLOOR PLANS

SCALE 1:100
DATE JANUARY 2006
DRAWN BY CPS

DRAWING No.
P12