


SITE PLAN
SCALE 1:200

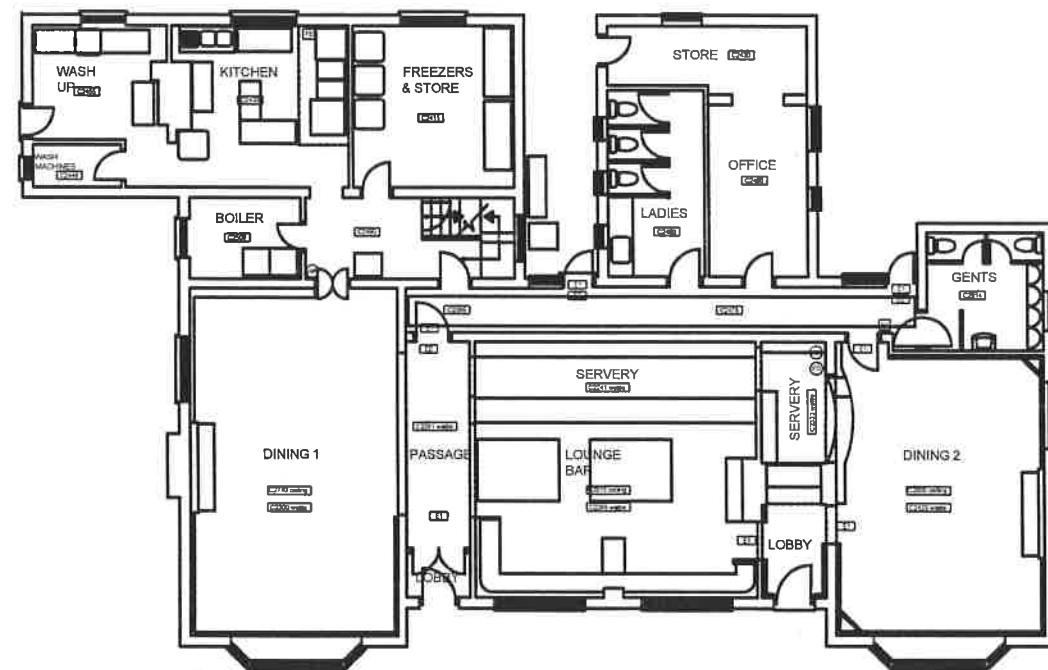

EXISTING GROUND FLOOR PLAN 2004

SCALE 1:100

NOTE:
Do not scale off this drawing. All dimensions to be checked on site by the Contractor. Any discrepancy to be reported to the Architect.

KEY

- N1 General Fire Notice
- N2 Staff Fire Notice
- N3 'Fire Door Keep Locked' sign
- N4 'Fire Exit Keep Clear' sign
- N5 'Fire Door Keep Closed' sign
- FB Fire Blanket
- DP Dry Powder Fire Extinguisher
- CC Carbon Dioxide Fire Extinguisher
- FC Foam Fire Extinguisher
- WA Water Fire Extinguisher
- E1 Emergency Light Fitting
- EE Emergency Exit Sign
- H Heat Detector
- S Smoke Detector
- C Break Glass Call Point
- FAS Fire Alarm Sounder
- FAP Fire Alarm Panel
- AWP Amusement with Prizes
- SWP Skill with Prizes
- ATM Cash machines
- PP Pay Phone
- C2860 Ceiling Height



CHARLES WELLS
PROPERTY SERVICES DEPARTMENT
THE BURNBY, HAYLOCK STREET,
BEDFORD MK40 4LL
Tel. 01234 572700 Fax. 01234 761056

HOUSE
DUCK ON THE POND
LONG ITCHINGTON

DRAWING
EXISTING GROUND FLOOR PLAN

SCALE 1:100 & 1:200
DATE OCTOBER 2004
DRAWN BY DWG

DRAWING No.