


EXISTING GROUND FLOOR PLAN  
 scale 1:50

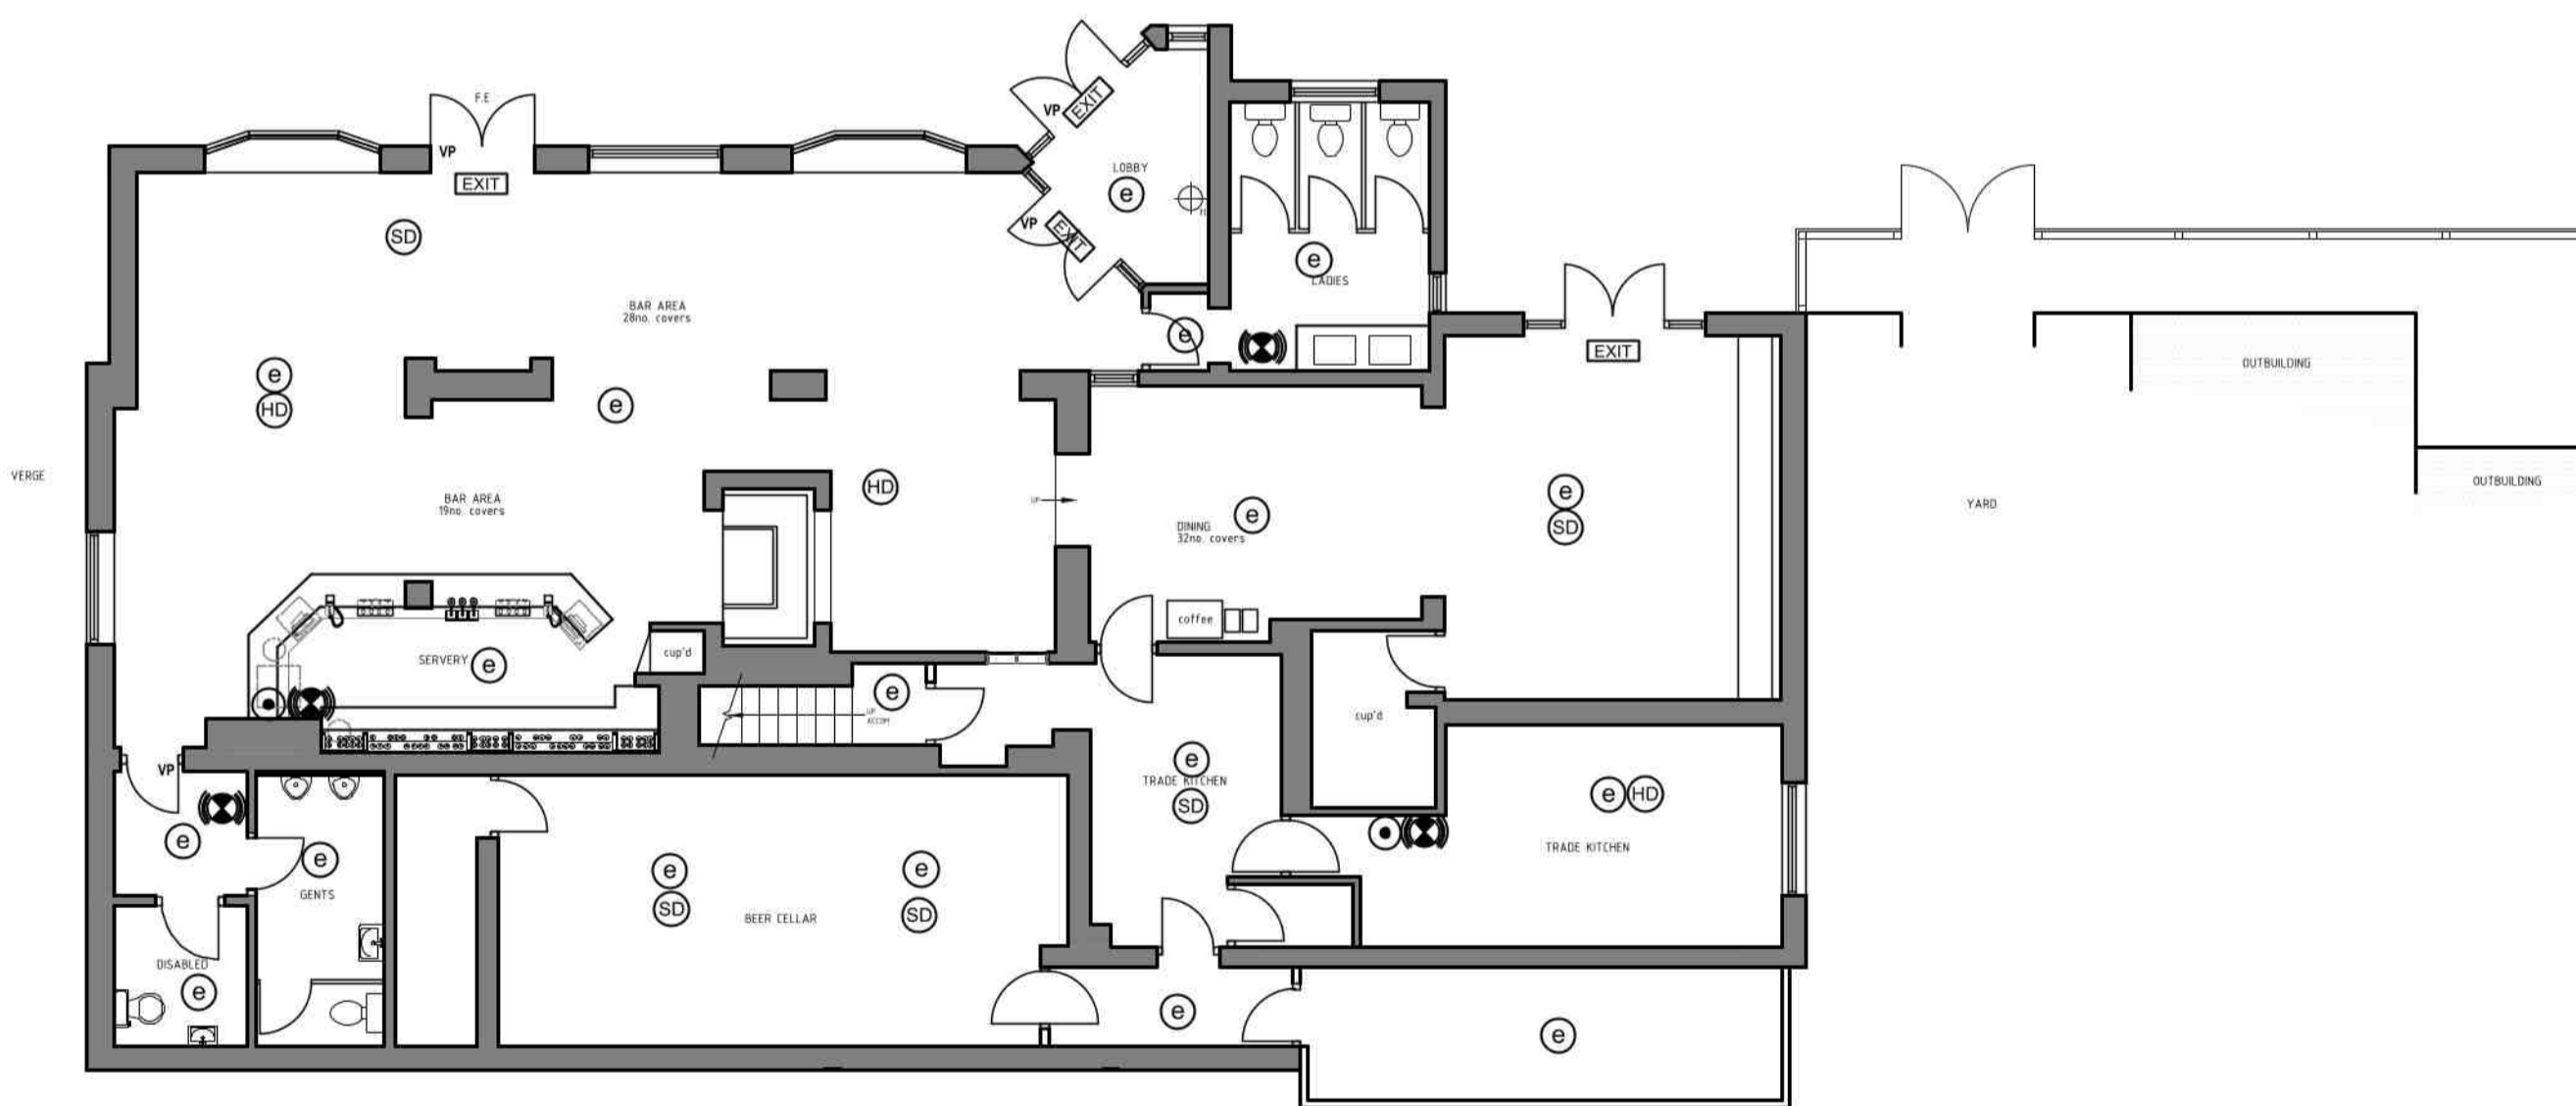

PROPOSED SITE PLAN  
 scale 1:250



PROPOSED GROUND FLOOR PLAN  
 scale 1:50

ref	key	description	reference	Quan.
		fire alarm panel *to be linked back to existing fire alarm panel	Main Contractor to supply unit, provide power & fit	
		internally illuminated fire exit or graphic equivalent - 75mm high letters (bs 5499) arrow indicates directional	Main Contractor to supply unit, provide power & fit	
		area covered by visible warning indicator & sounder at high level - (bs 5839)	Main Contractor to supply unit, provide power & fit	
		Area to covered by non-maintained emergency luminaire (bs 5266)	Main Contractor to supply unit, provide power & fit	
		area covered by smoke detector (bs 5839)	Main Contractor to supply unit, provide power & fit	
ref	key	description	reference	Quan.
		manual call point (bs 5839)	Main Contractor to supply unit, provide power & fit	
		area covered by heat detector (bs 5839)	Main Contractor to supply unit, provide power & fit	
		Push bar or single action fastening to be available when the premises are in use	Main Contractor to supply & fit	
		self closing - opening force limited to 20 newtons to comply with Building Regulations Doc. M	Main Contractor to supply & fit	
		30 min fire resistant doorset with intumescent strip, smoke seal & self closer.	Main Contractor to supply & fit	
ref	key	description	reference	Quan.
		Vision panel - refer to FD30 / FD650's specifications.	Main Contractor to supply & fit	
		magnetic door holder to be inter linked with fire alarm system	Main Contractor to supply unit, provide power & fit	



St Matthews House, 1 Brick Row, Darley Abbey, Derby, DE22 1DQ  
 T: 07496 34 00 50 email: studio@keenasmustarddesign.com

Client  
 WELLS & CO

Project  
 THE BELL  
 STOKE MANDEVILLE

Drawing  
 EXISTING AND PROPOSED  
 LICENSING PLAN

Drawing No. 565-30 Rev /

Scale 1:50 Size A1 Drawn DK Date 02.07.21

ALL DIMENSIONS, SETTING OUT AND LEVELS MUST BE CHECKED ON SITE AND NOT SCALED OFF THIS DRAWING BEFORE ORDERING AND STARTING WORK ON SITE.  
 © KEEN AS MUSTARD DESIGN STUDIO

- PLANNING
- PRELIMINARY
- TENDER
- CONSTRUCTION
- AS BUILT

